
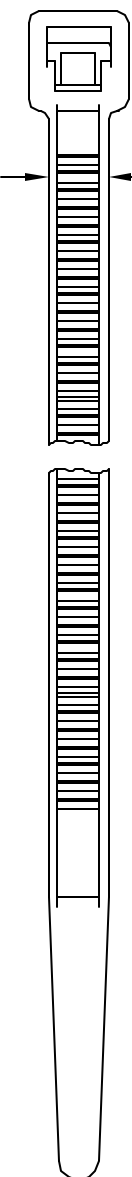


REVISIONS		DDC. NO. SPC-FD05, Total Pages: 2						
DCP #	REV	DESCRIPTION	Effective: 7/15/97, DCP No: 229	Supersedes DCP No: 103				
09	A	RELEASED	J.W.M.	10/8/97	J.C.	10/27/97	B.B.	11/4/97
421	B	Electronic file name change	J.W.M.	2/5/98	J.C.	2/5/98	J.C.	2/5/98

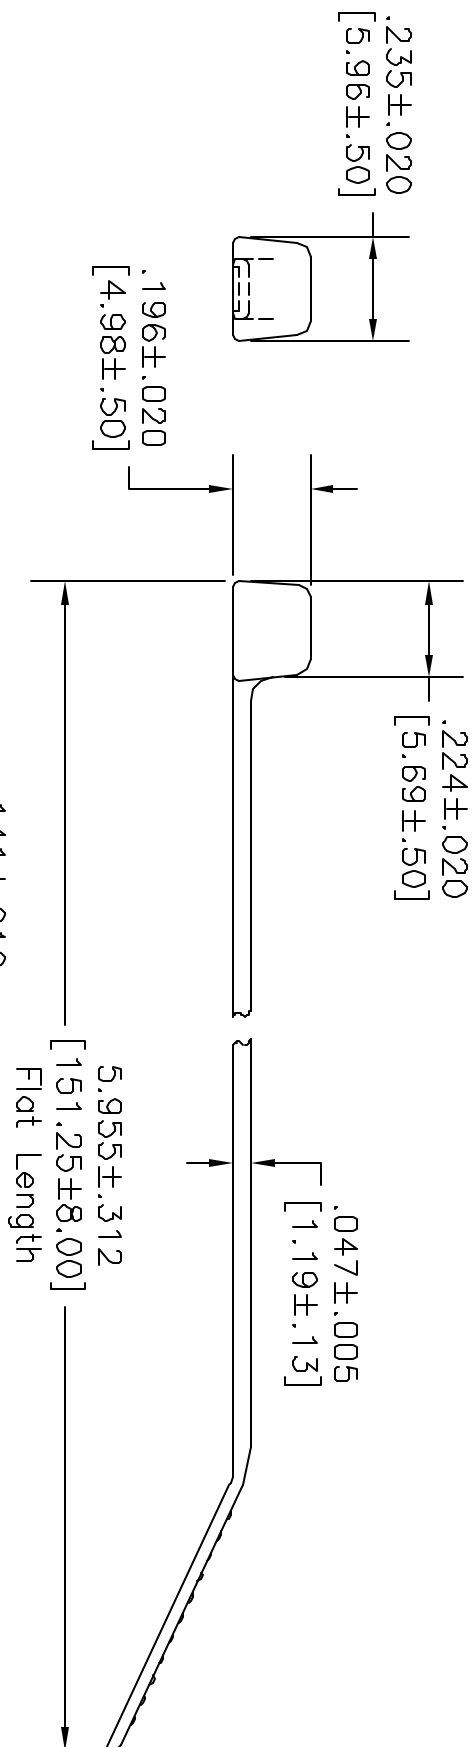

NOTES:
 Material: Nylon 6/6-HSO
 Color: Black
 Packed: 1000 to Bag
 Max. Bundle Dia: 1.250 [31.75]
 Min. Bundle Dia: .063 [1.59]
 Min. Loop Tensile Strength: 30lbs.

DISCLAIMER
 ALL STATEMENTS AND TECHNICAL INFORMATION CONTAINED HEREIN ARE BASED UPON INFORMATION AND/OR TESTS WE BELIEVE TO BE ACCURATE AND RELIABLE. SINCE CONDITIONS OF USE ARE BEYOND OUR CONTROL, THE USER SHALL DETERMINE THE SUITABILITY OF THE PRODUCT FOR THE INTENDED USE AND ASSUME ALL RISK AND LIABILITY WHATSOEVER IN CONNECTION THEREWITH.

Dimensional Specifications
 Dimensions are shown for reference only! Your own tests will determine the suitability of this product for your application.

DRAWN BY:	DATE:
Jeff McVicker	10/8/97
CHECKED BY:	DATE:
JOHN COLE	10/27/97
APPROVED BY:	DATE:
BRETT BRAATZ	11/4/97

SPC TECHNOLOGY
 CINCINNATI, OH 60940-4198

DRAWING TITLE: Cable Tie - Heat Stabilized

SIZE	DWG. NO.	ELECTRONIC FILE	REV
A	8409-0376	16N866.dwg	B
SCALE:	NTS	U.O.M.: INCHES [mm]	SHEET: 1 OF 1