
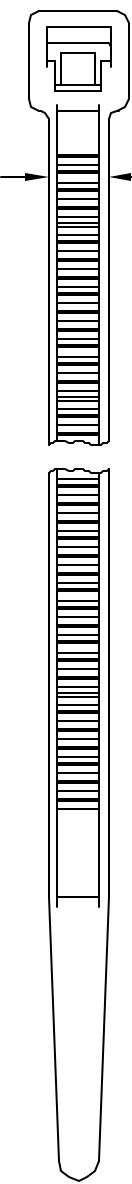


REVISIONS		DDC. NO. SPC-FD05, Total Pages: 2
09	REV	Effective: 7/15/97, DCP No: Z29, Supersedes DCP No: 103
09	REV	DESCRIPTION
09	A	RELEASED
421	B	Electronic file name change
		DRAWN DATE CHECKED DATE APPROVD DATE
		J.W.M. 10/8/97 J.C. 10/24/97 B.B. 11/4/97
		J.W.M. 2/5/98 J.C. 2/5/98 J.C. 2/5/98

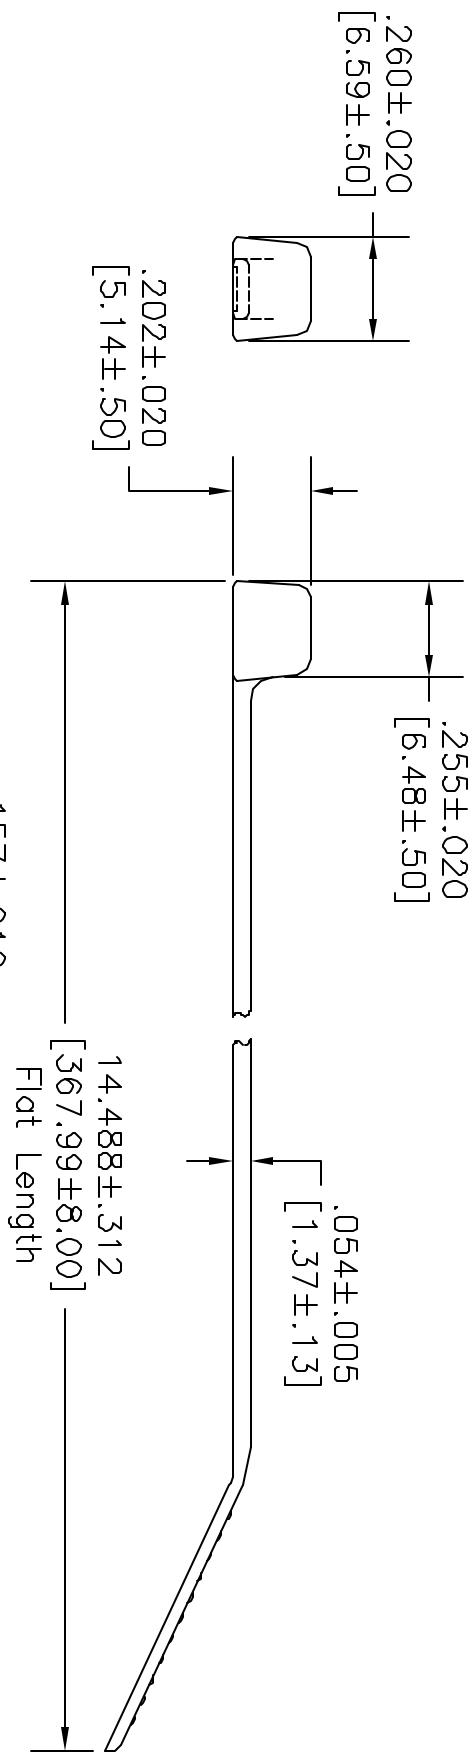

NOTES:  
 Material: Nylon 6/6-HSO  
 Color: Black  
 Packed: 100 to Bag  
 Max. Bundle Dia: 4.00 [101.6]  
 Min. Bundle Dia: .063 [1.59]  
 Min. Loop Tensile Strength: 40lbs.

DISCLAIMER  
 ALL STATEMENTS AND TECHNICAL INFORMATION CONTAINED HEREIN ARE BASED UPON INFORMATION AND/OR TESTS WE BELIEVE TO BE ACCURATE AND RELIABLE. SINCE CONDITIONS OF USE ARE BEYOND OUR CONTROL, THE USER SHALL DETERMINE THE SUITABILITY OF THE PRODUCT FOR THE INTENDED USE AND ASSUME ALL RISK AND LIABILITY WHATSOEVER IN CONNECTION THEREWITH.

Dimensional Specifications  
 Dimensions are shown for reference only! Your own tests will determine the suitability of this product for your application.

DRAWN BY:	DATE:
Jeff McVicker	10/8/97
CHECKED BY:	DATE:
JOHN COLE	10/24/97
APPROVED BY:	DATE:
BRETT BRAATZ	11/4/97

**SPC TECHNOLOGY**  
 602400, LL 60040-4198

DRAWING TITLE:		Cable Tie - Heat Stabilized	
SIZE	DWG. NO.	ELECTRONIC FILE	REV
A	8409-0387	16N877.dwg	B
SCALE:	NTS	U.O.M.: INCHES [mm]	SHEET: 1 OF 1