


© COPYRIGHT 1997 BY SPC TECHNOLOGY. ALL RIGHTS RESERVED. NO PORTION OF THIS PUBLICATION, WHETHER IN WHOLE OR IN PART CAN BE REPRODUCED WITHOUT THE EXPRESS WRITTEN CONSENT OF SPC TECHNOLOGY.

| REVISIONS | | DDC. NO. SPC-FD05, Total Pages: 2 | | | | | | |
|-----------|-----|-----------------------------------|--------|----------|--------|----------|--------|---------|
| DCP # | REV | DESCRIPTION | DRAWN | DATE | CHECKD | DATE | APPRVD | DATE |
| 09 | A | RELEASED | J.W.M. | 10/16/97 | J.C. | 10/27/97 | B.B. | 11/4/97 |
| 421 | B | Electronic file name change | J.W.M. | 2/5/98 | J.C. | 2/5/98 | J.C. | 2/5/98 |

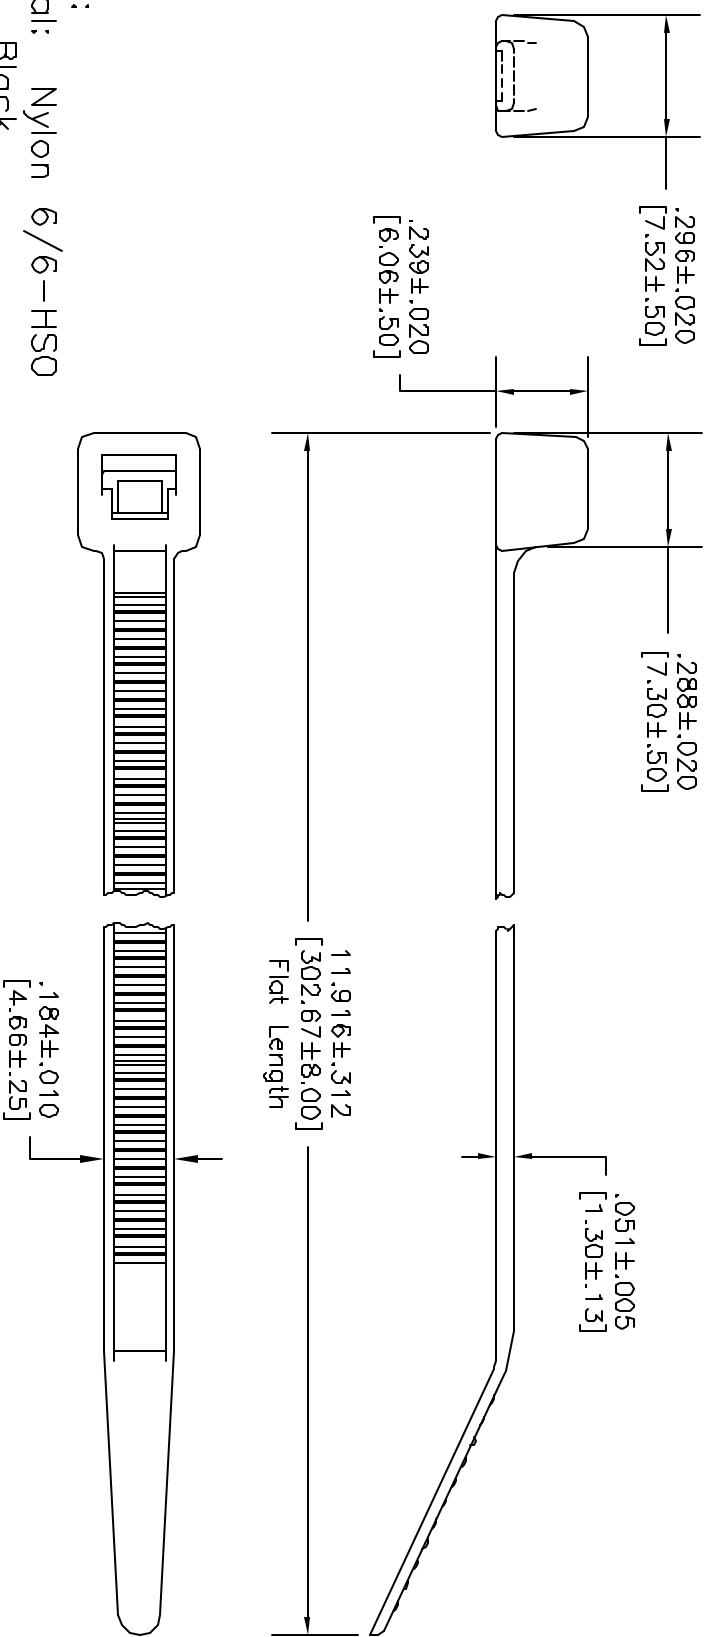

NOTES:
 Material: Nylon 6/6-HSO
 Color: Black
 Packed: 1000 to bag
 Max. Bundle Dia: 3.000 [76.20]
 Min. Bundle Dia: .063 [1.60]
 Min. Loop Tensile Strength: 50lbs.

DISCLAIMER
 ALL STATEMENTS AND TECHNICAL INFORMATION CONTAINED HEREIN ARE BASED UPON INFORMATION AND/OR TESTS WE BELIEVE TO BE ACCURATE AND RELIABLE. SINCE CONDITIONS OF USE ARE BEYOND OUR CONTROL, THE USER SHALL DETERMINE THE SUITABILITY OF THE PRODUCT FOR THE INTENDED USE AND ASSUME ALL RISK AND LIABILITY WHATSOEVER IN CONNECTION THEREWITH.

Drawers Other than Specified Dimensions are shown for reference only! Your own tests will determine the suitability of this product for your application.

| | | | | | | |
|---------------|----------|-----------------------------|------|---------------------|-----------------|--------|
| DRAWN BY: | DATE: | DRAWING TITLE: | SIZE | DWG. NO. | ELECTRONIC FILE | REV |
| Jeff McVicker | 10/16/97 | Cable Tie - Heat Stabilized | A | 8409-0394 | 16N884.DWG | B |
| CHECKED BY: | DATE: | SCALE: | NTS | U.O.M.: INCHES [mm] | SHEET: | 1 OF 1 |
| JOHN COLE | 10/27/97 | | | | | |
| APPROVED BY: | DATE: | | | | | |
| BRETT BRAATZ | 11/4/97 | | | | | |

SPC TECHNOLOGY
 60231604, LL 60040-4198