
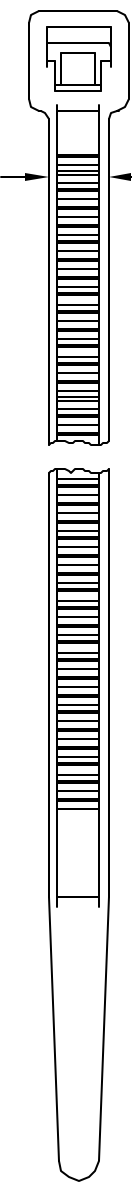


© COPYRIGHT 1997 BY SPC TECHNOLOGY. ALL RIGHTS RESERVED. NO PORTION OF THIS PUBLICATION, WHETHER IN WHOLE OR IN PART CAN BE REPRODUCED WITHOUT THE EXPRESS WRITTEN CONSENT OF SPC TECHNOLOGY.

REVISIONS		DDC. NO. SPC-F005, Total Pages: 2						
DCP #	REV	DESCRIPTION	DRAWN	DATE	CHECKD	DATE	APPRVD	DATE
09	A	RELEASED	J.W.M.	10/8/97	J.C.	10/24/97	B.B.	11/4/97
421	B	Electronic file name changed	J.W.M.	2/5/98	J.C.	2/5/98	J.C.	2/5/98

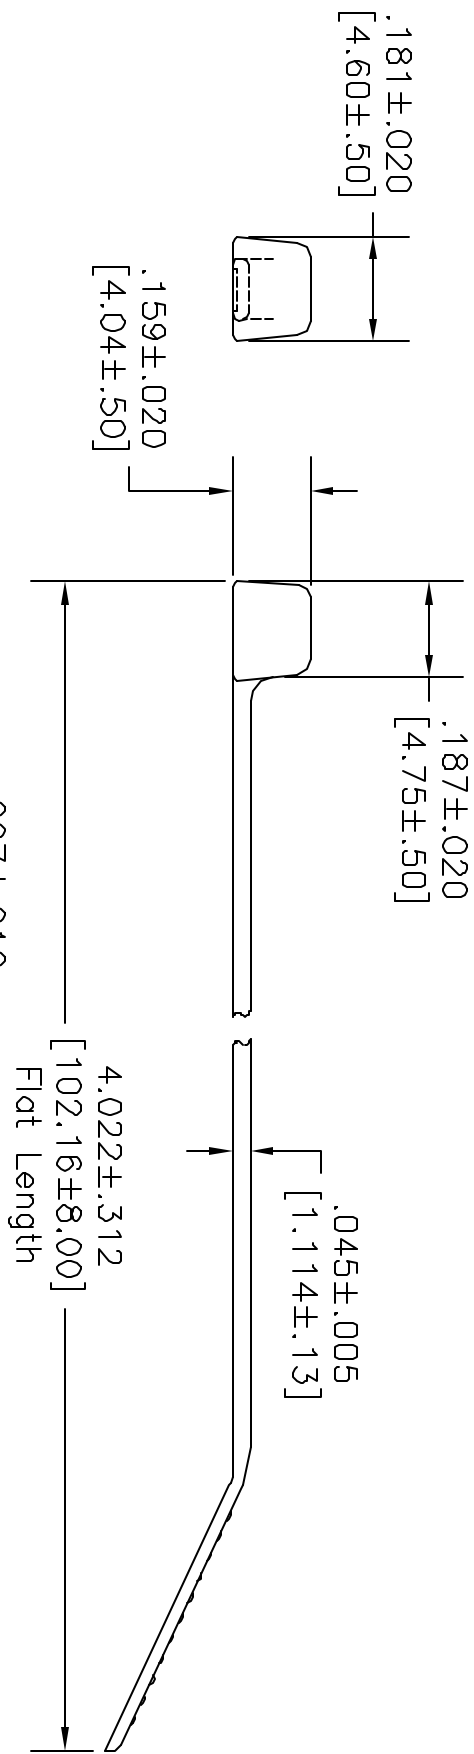

NOTES:
 Material: Nylon 6/6-HSO
 Color: Black
 Packed: 1000 to Bag
 Max. Bundle Dia: 1.250 [31.75]
 Min. Bundle Dia: .063 [1.59]
 Min. Loop Tensile Strength: 18lbs.

DISCLAIMER
 ALL STATEMENTS AND TECHNICAL INFORMATION CONTAINED HEREIN ARE BASED UPON INFORMATION AND/OR TESTS WE BELIEVE TO BE ACCURATE AND RELIABLE. SPC TECHNOLOGY DOES NOT WARRANT THAT THE INFORMATION CONTAINED HEREIN IS COMPLETE, CORRECT, OR THAT THE INFORMATION WILL BE USED FOR THE INTENDED USE AND ASSUME ALL RISK AND LIABILITY WHATSOEVER IN CONNECTION THEREWITH.

Dimensional Specifications
 Dimensions are shown for reference only! Your own tests will determine the suitability of this product for your application.

DRAWN BY:	DATE:	DRAWING TITLE:	SCALE:	U.O.M.: INCHES [mm]	SHEET: 1 OF 1
Jeff McVicker	10/8/97	Cable Tie - Heat Stabilized	NTS		
CHECKED BY:	DATE:				
JOHN COLE	10/24/97	SIZE DWG. NO.			
APPROVED BY:	DATE:	8409-0370			
BRETT BRAATZ	11/4/97	ELECTRONIC FILE			
		16N860.dwg			
		REV			
		B			

