
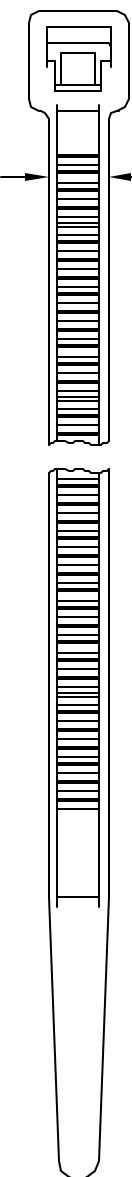


REVISIONS		DDC. NO. SPC-FD05, Total Pages: 2						
09	A	RELEASED						
421	B	Electronic file name changed						
DCP #	REV	DESCRIPTION	DRAWN	DATE	CHECKD	DATE	APPRVD	DATE
09	A	RELEASED	J.W.M.	10/8/97	J.C.	10/27/97	B.B.	11/4/97
421	B	Electronic file name changed	J.W.M.	2/5/98	J.C.	2/5/98	J.C.	2/5/98

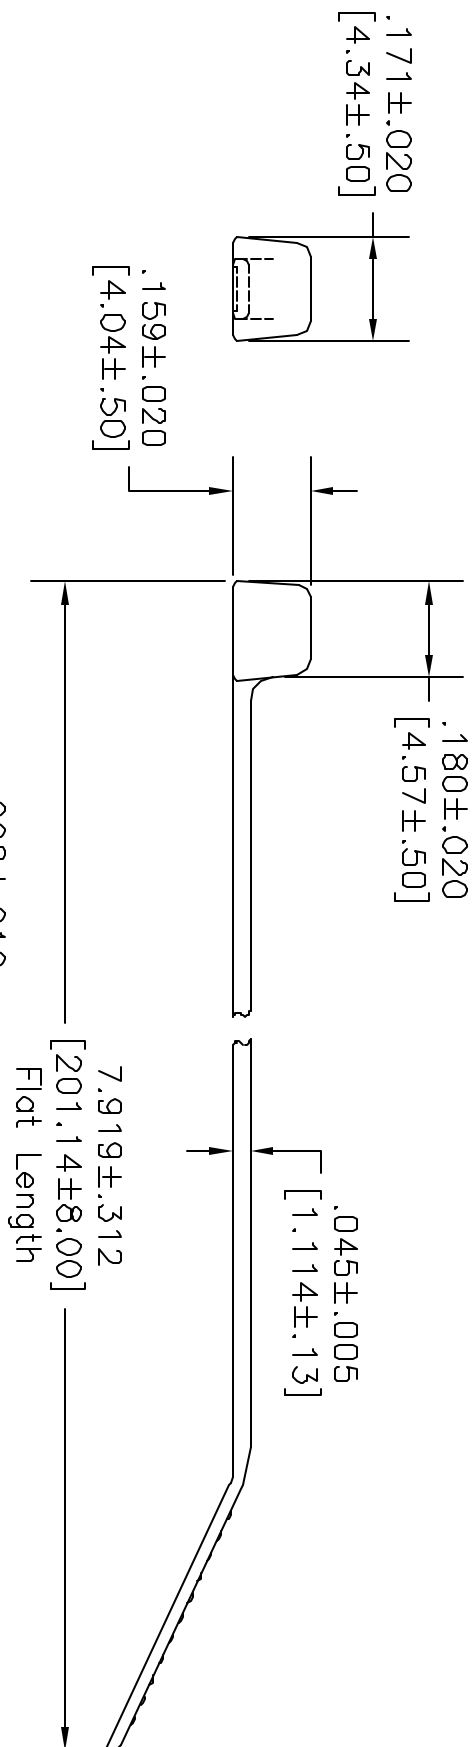

NOTES:
 Material: Nylon 6/6-HSO
 Color: Black
 Packed: 100 to Bag
 Max. Bundle Dia: 2.000 [50.80]
 Min. Bundle Dia: .063 [1.59]
 Min. Loop Tensile Strength: 18lbs.

DISCLAIMER
 ALL STATEMENTS AND TECHNICAL INFORMATION CONTAINED HEREIN ARE BASED UPON INFORMATION AND/OR TESTS WE BELIEVE TO BE ACCURATE AND RELIABLE. SINCE CONDITIONS OF USE ARE BEYOND OUR CONTROL, THE USER SHALL DETERMINE THE SUITABILITY OF THE PRODUCT FOR THE INTENDED USE AND ASSUME ALL RISK AND LIABILITY WHATSOEVER IN CONNECTION THEREWITH.

Dimensional Specifications
 Dimensions are shown for reference only! Your own tests will determine the suitability of this product for your application.

DRAWN BY:	DATE:
Jeff McVicker	10/8/97
CHECKED BY:	DATE:
JOHN COLE	10/24/97
APPROVED BY:	DATE:
BRETT BRAATZ	11/4/97

SPC TECHNOLOGY
 6024100, LL 60040-4100

DRAWING TITLE:		Cable Tie - Heat Stabilized	
SIZE	DWG. NO.	ELECTRONIC FILE	REV
A	8409-0372	16N862.dwg	B
SCALE:	NTS	U.O.M.: INCHES [mm]	SHEET: 1 OF 1