


© COPYRIGHT 1997 BY SPC TECHNOLOGY. ALL RIGHTS RESERVED. NO PORTION OF THIS PUBLICATION, WHETHER IN WHOLE OR IN PART CAN BE REPRODUCED WITHOUT THE EXPRESS WRITTEN CONSENT OF SPC TECHNOLOGY.

REVISIONS		DDC. NO. SPC-FD05, Total Pages: 2						
DCP #	REV	DESCRIPTION	DRAWN	DATE	CHECKD	DATE	APPRVD	DATE
09	A	RELEASED	J.W.M.	10/16/97	J.C.	10/27/97	B.B.	11/4/97
421	B	Electronic file name change	J.W.M.	2/5/98	J.C.	2/5/98	J.C.	2/5/98

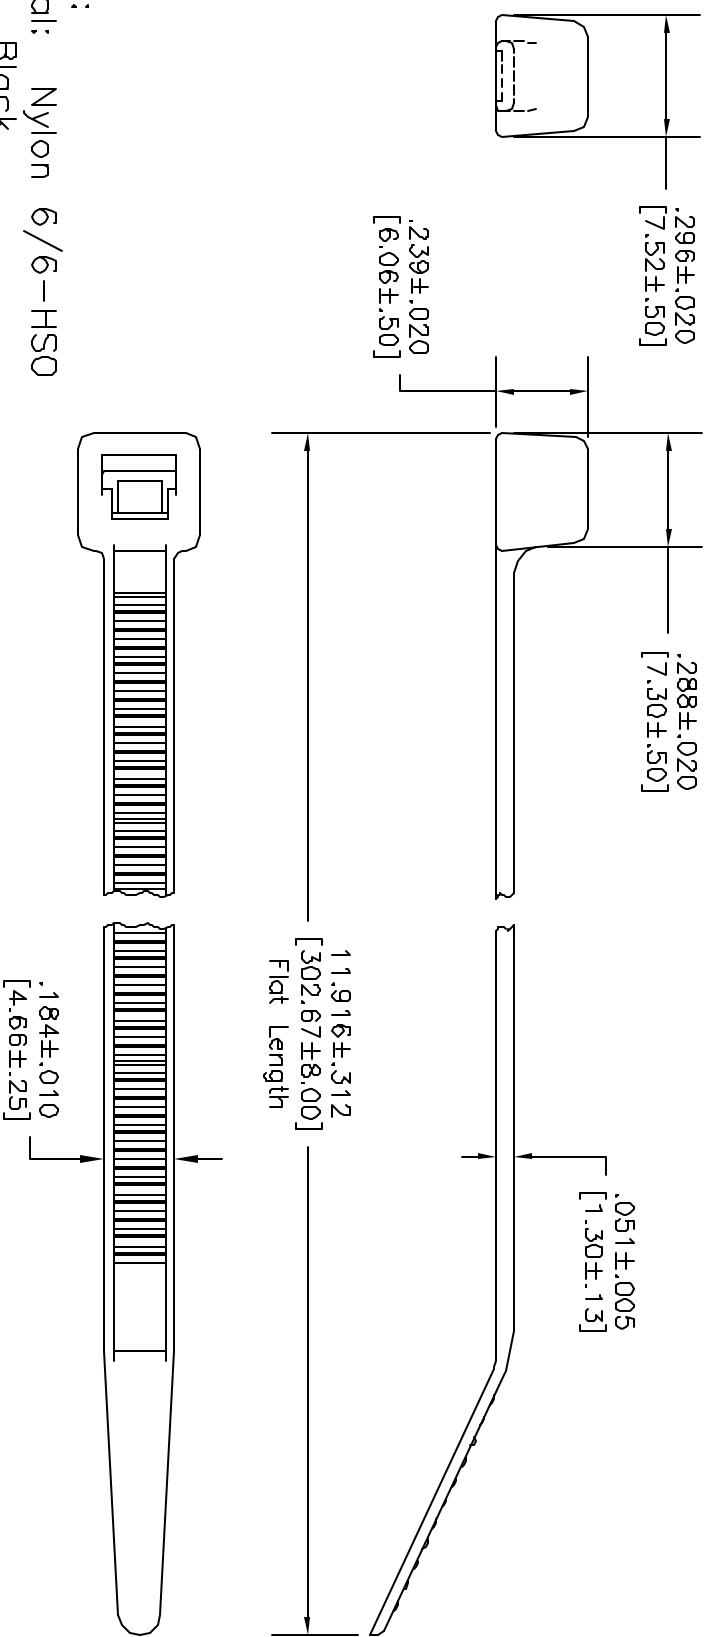

NOTES:  
 Material: Nylon 6/6-HSO  
 Color: Black  
 Packed: 100 to bag  
 Max. Bundle Dia: 3.000 [76.20]  
 Min. Bundle Dia: .063 [1.60]  
 Min. Loop Tensile Strength: 50lbs.

**DISCLAIMER**  
 ALL STATEMENTS AND TECHNICAL INFORMATION CONTAINED HEREIN ARE BASED UPON INFORMATION AND/OR TESTS WE BELIEVE TO BE ACCURATE AND RELIABLE. SINCE CONDITIONS OF USE ARE BEYOND OUR CONTROL, THE USER SHALL DETERMINE THE SUITABILITY OF THE PRODUCT FOR THE INTENDED USE AND ASSUME ALL RISK AND LIABILITY WHATSOEVER IN CONNECTION THEREWITH.

**Drawers Other than Specified Dimensions are shown for reference only! Your own tests will determine the suitability of this product for your application.**

DRAWN BY:	DATE:	DRAWING TITLE:	SIZE	DWG. NO.	ELECTRONIC FILE	REV
Jeff McVicker	10/16/97	Cable Tie - Heat Stabilized	A	8409-0393	16N883.DWG	B
CHECKED BY:	DATE:	SCALE:	NTS	U.O.M.: INCHES [mm]	SHEET:	1 OF 1
JOHN COLE	10/27/97					
APPROVED BY:	DATE:					
BRETT BRAATZ	11/4/97					

**SPC TECHNOLOGY**  
 6023160, LL 60040-4198