
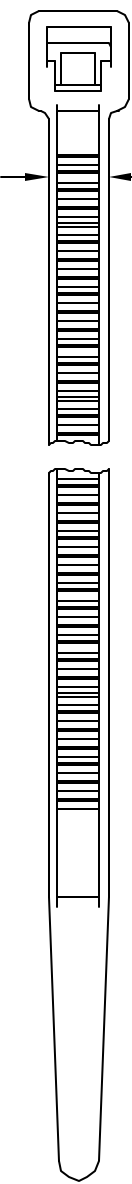


REVISIONS		DDC. NO. SPC-FD05, Total Pages: 2						
09	A	RELEASED						
421	B	Electronic file name changed						
DCP #	REV	DESCRIPTION	DRAWN	DATE	CHECKD	DATE	APPRVD	DATE
09	A	RELEASED	J.W.M.	10/8/97	J.C.	10/27/97	B.B.	11/4/97
421	B	Electronic file name changed	J.W.M.	2/5/98	J.C.	2/5/98	J.C.	2/5/98

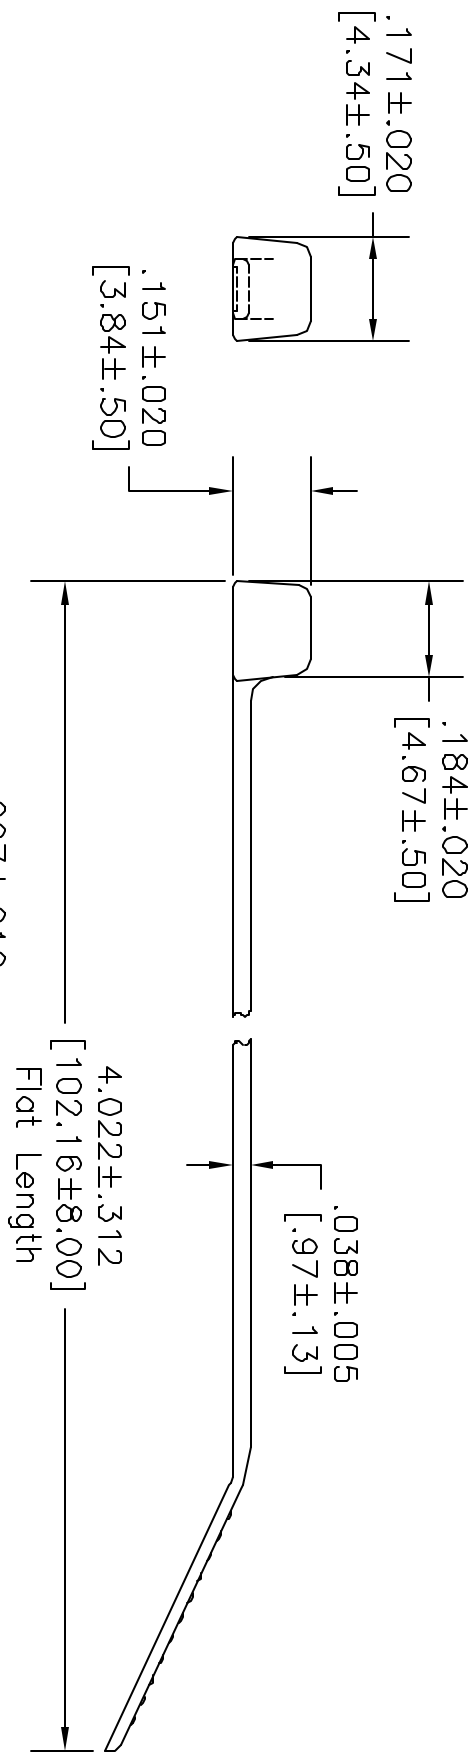

NOTES:  
 Material: Nylon 6/6-HSO  
 Color: Black  
 Packed: 100 to Bag  
 Max. Bundle Dia: .750 [19.05]  
 Min. Bundle Dia: .063 [1.59]  
 Min. Loop Tensile Strength: 18lbs.

**DISCLAIMER**  
 ALL STATEMENTS AND TECHNICAL INFORMATION CONTAINED HEREIN ARE BASED UPON INFORMATION AND/OR TESTS WE BELIEVE TO BE ACCURATE AND RELIABLE. SOME CONDITIONS OF USE ARE NOT MENTIONED BUT SHOULD BE OBSERVED. THE USER SHALL DETERMINE THE SUITABILITY OF THE PRODUCT FOR THE INTENDED USE AND ASSUME ALL RISK AND LIABILITY WHATSOEVER IN CONNECTION THEREWITH.

**Usual Observation Specified**  
 Dimensions are shown for reference only. Your own tests will determine the suitability of this product for your application.

DRAWN BY:	DATE:
Jeff McVicker	10/8/97
CHECKED BY:	DATE:
JOHN COLE	10/27/97
APPROVED BY:	DATE:
BRETT BRAATZ	11/4/97

**SPC TECHNOLOGY**  
 6000 W. 11th St. #100  
 Overland Park, KS 66204-4198

DRAWING TITLE:		Cable Tie - Heat Stabilized	
SIZE:	DWG. NO.:	ELECTRONIC FILE	REV
A	8409-0367	16N857.dwg	B
SCALE:	NTS	U.O.M.: INCHES [mm]	SHEET: 1 OF 1